
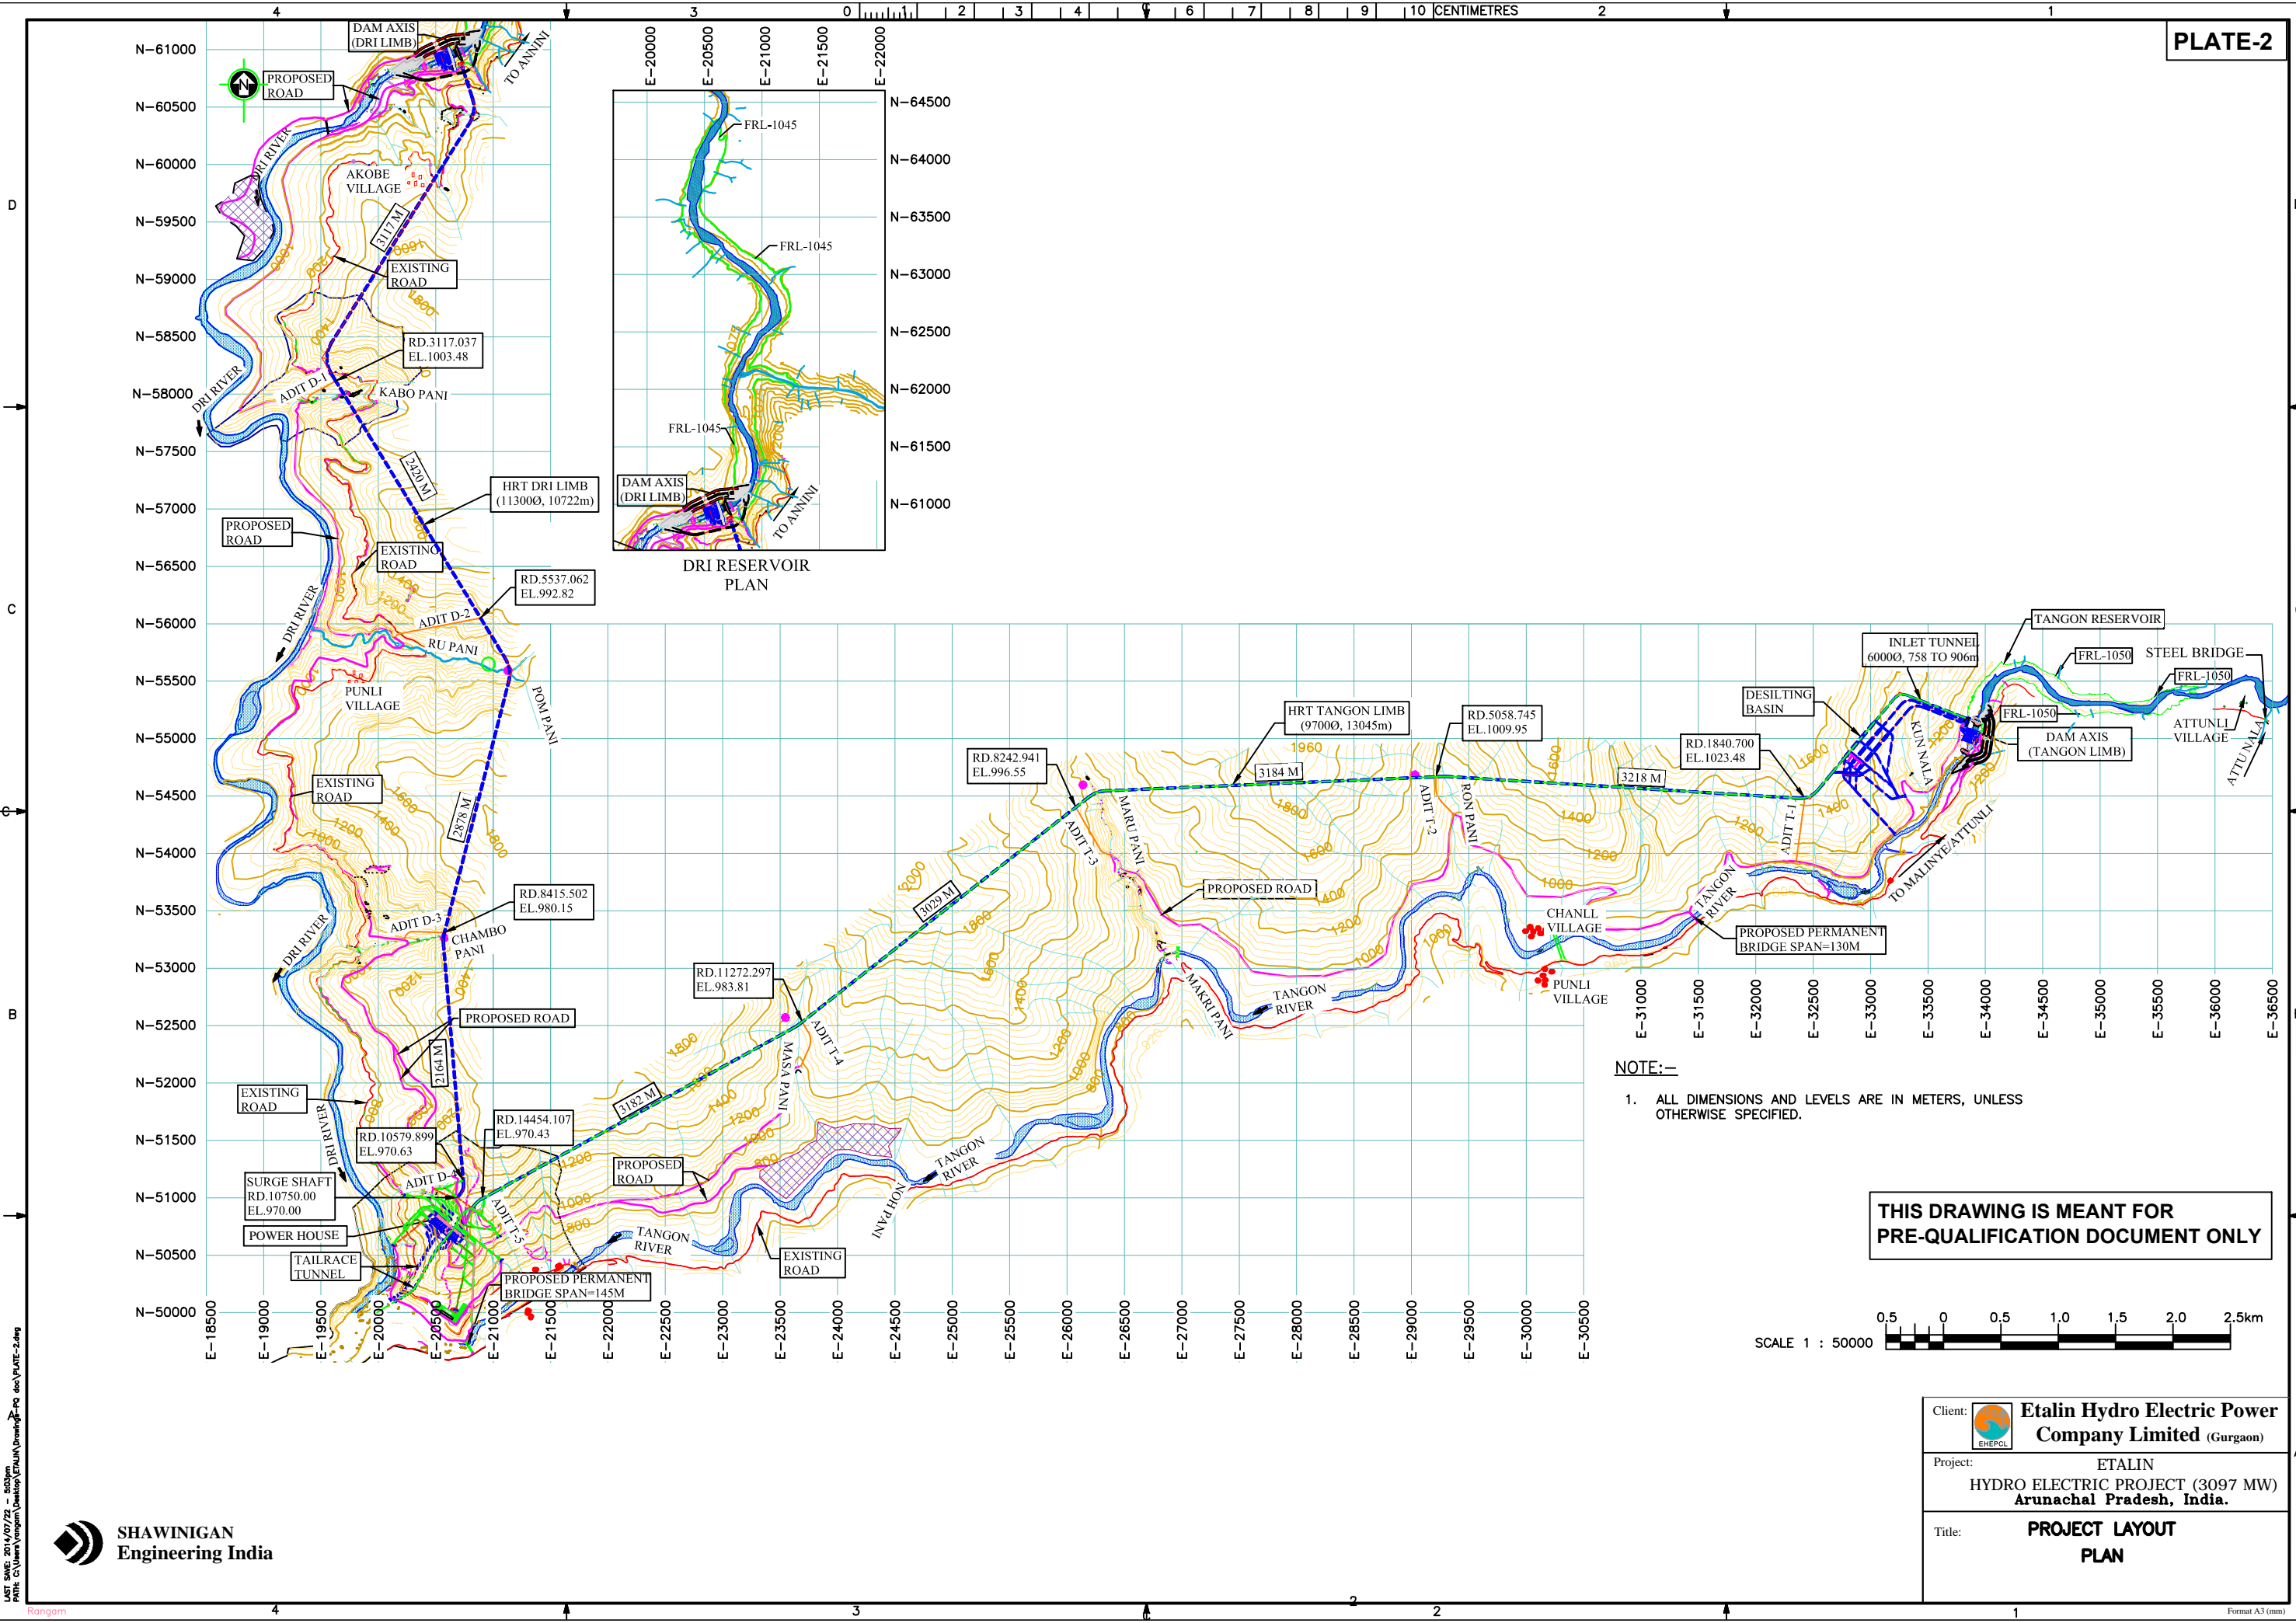



THIS DRAWING IS MEANT FOR
PRE-QUALIFICATION DOCUMENT ONLY

Client:	 Etalin Hydro Electric Power Company Limited (Gurgaon)
Project:	ETALIN HYDRO ELECTRIC PROJECT (3097 MW) Arunachal Pradesh, India.
Title:	PROJECT LOCATION PLAN




NOTE:-
 1. ALL DIMENSIONS AND LEVELS ARE IN METERS, UNLESS OTHERWISE SPECIFIED.

 
THIS DRAWING IS MEANT FOR PRE-QUALIFICATION DOCUMENT ONLY




Client:	Etalin Hydro Electric Power Company Limited (Gurgaon)
Project:	ETALIN HYDRO ELECTRIC PROJECT (3097 MW) Arunachal Pradesh, India.
Title:	PROJECT LAYOUT PLAN

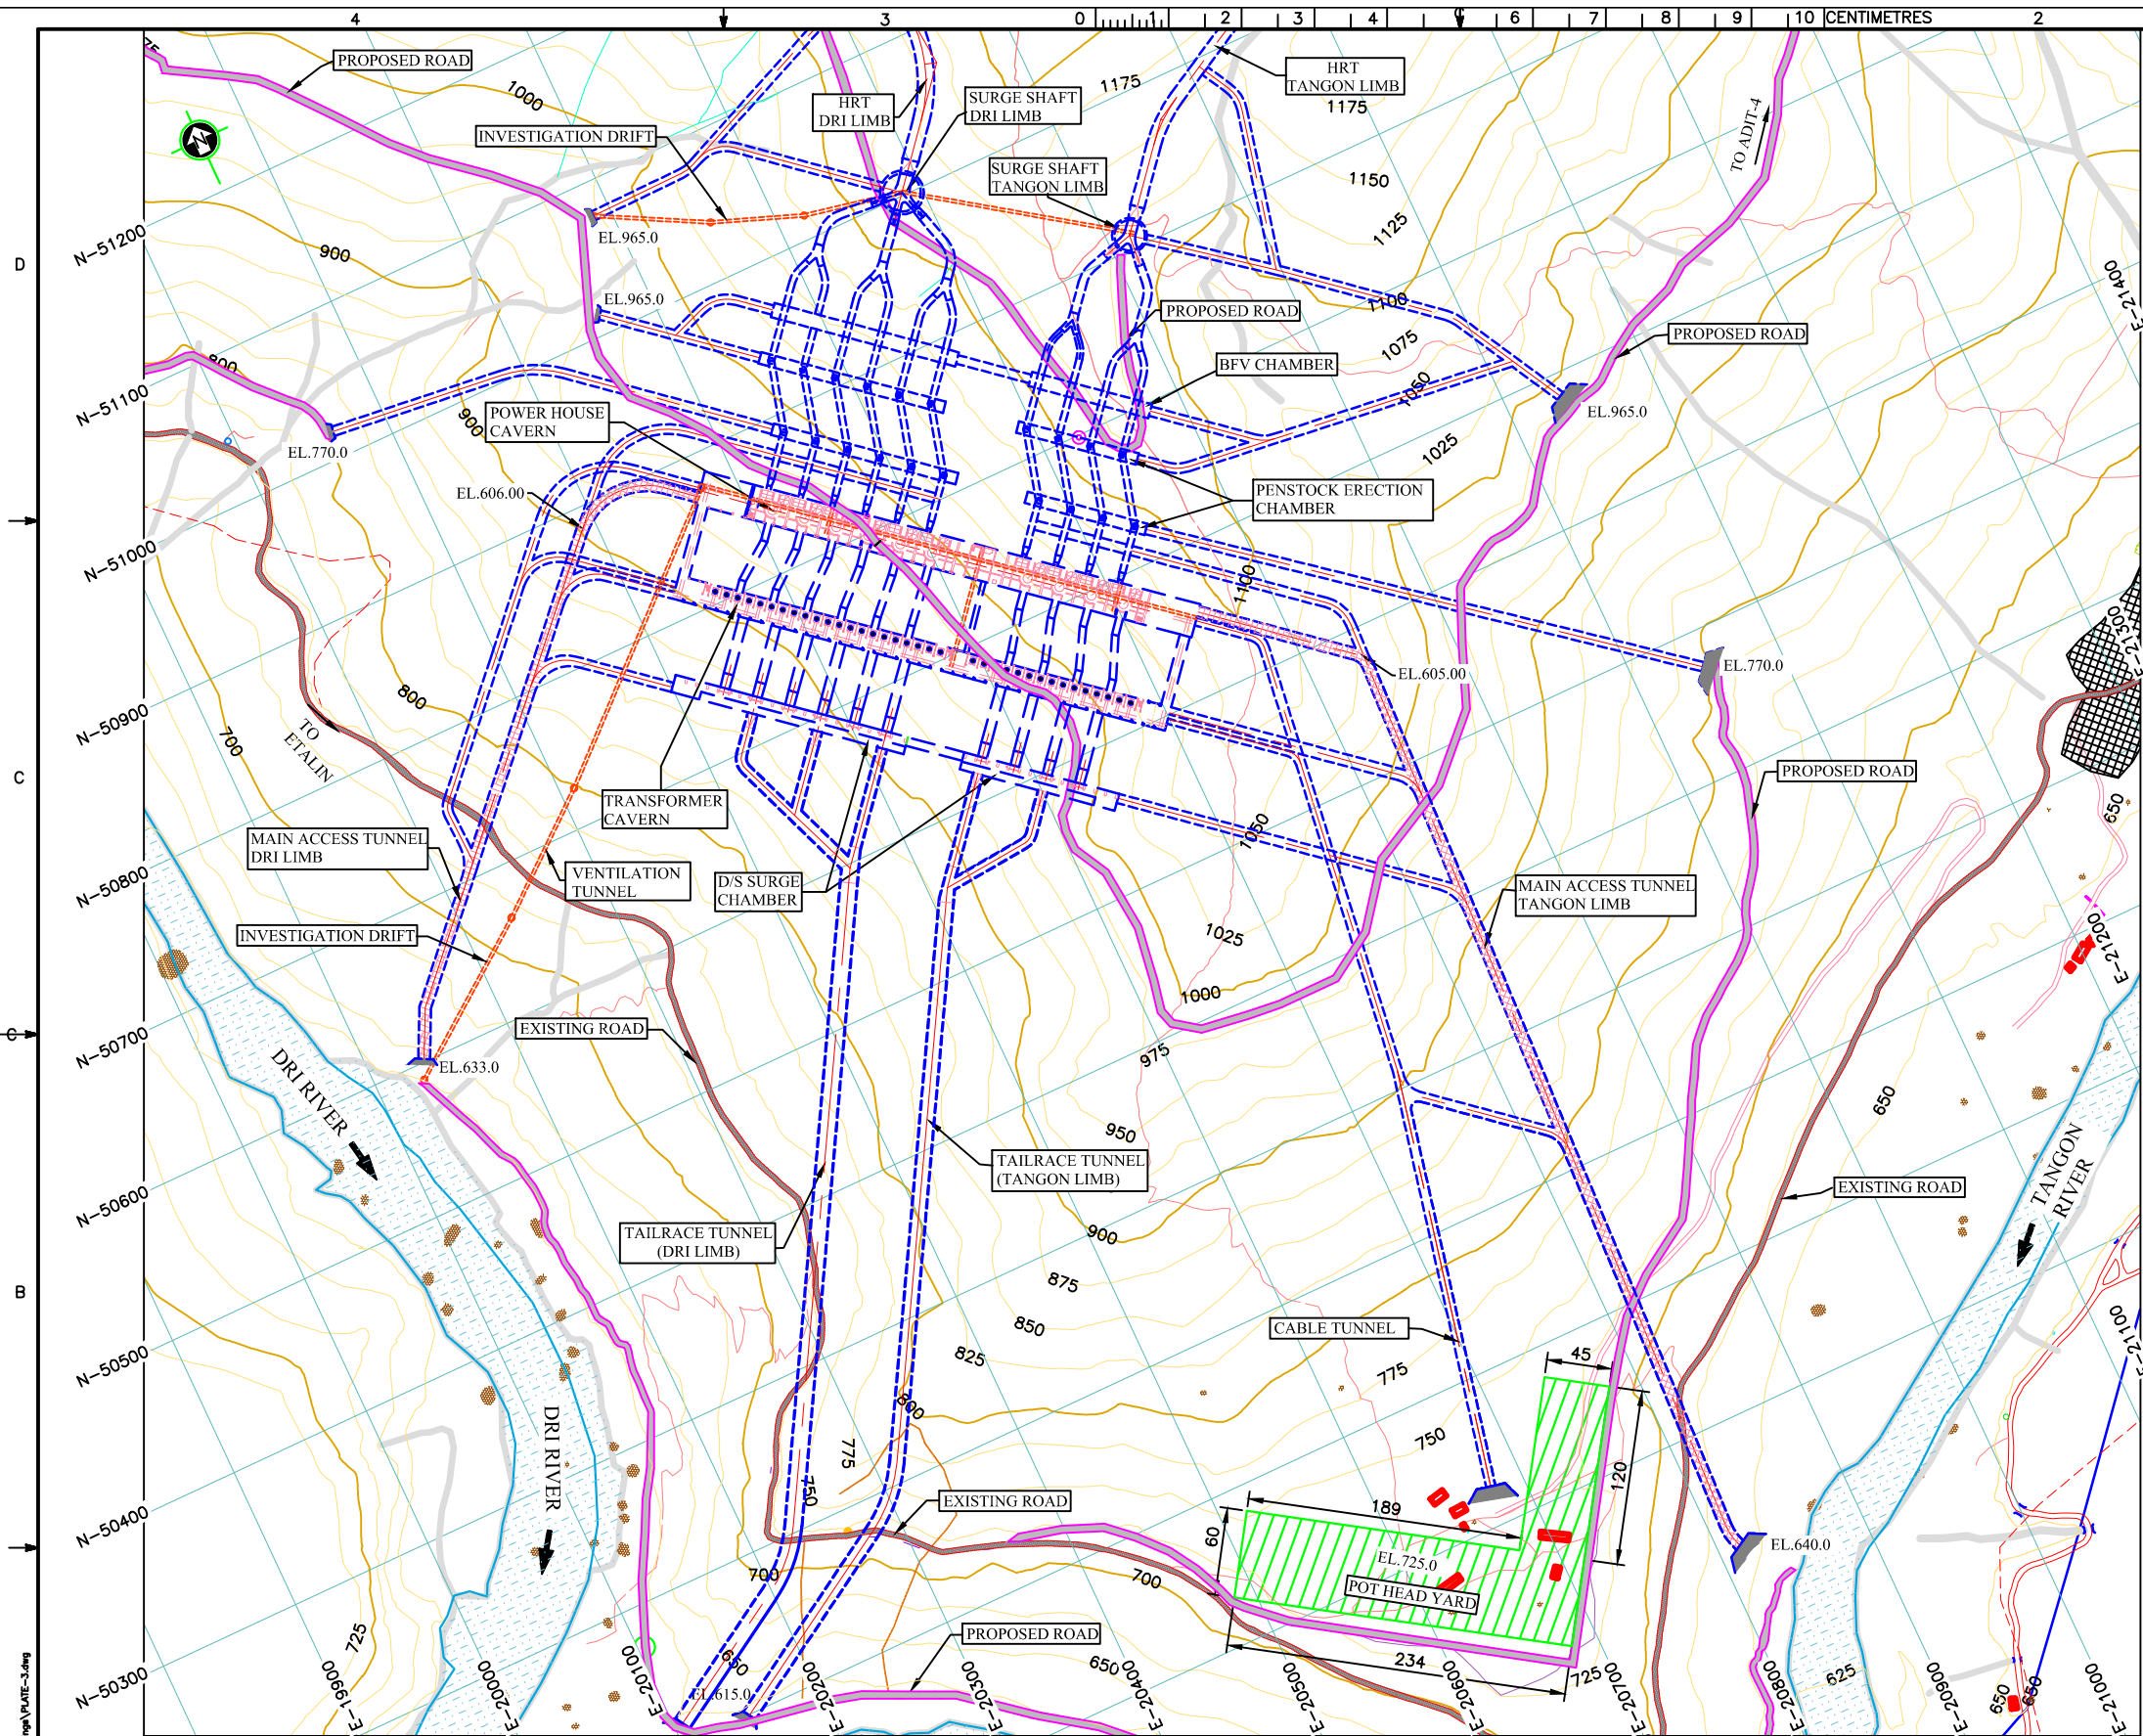


 THIS DRAWING IS MEANT FOR PRE-QUALIFICATION DOCUMENT ONLY




LAYOUT PLAN (SCALE 1:5000)


Client:	 Etalin Hydro Electric Power Company Limited (Gurgaon)
Project:	ETALIN HYDRO ELECTRIC PROJECT (3097 MW) Arunachal Pradesh, India.
Title:	POWER HOUSE LAYOUT PLAN

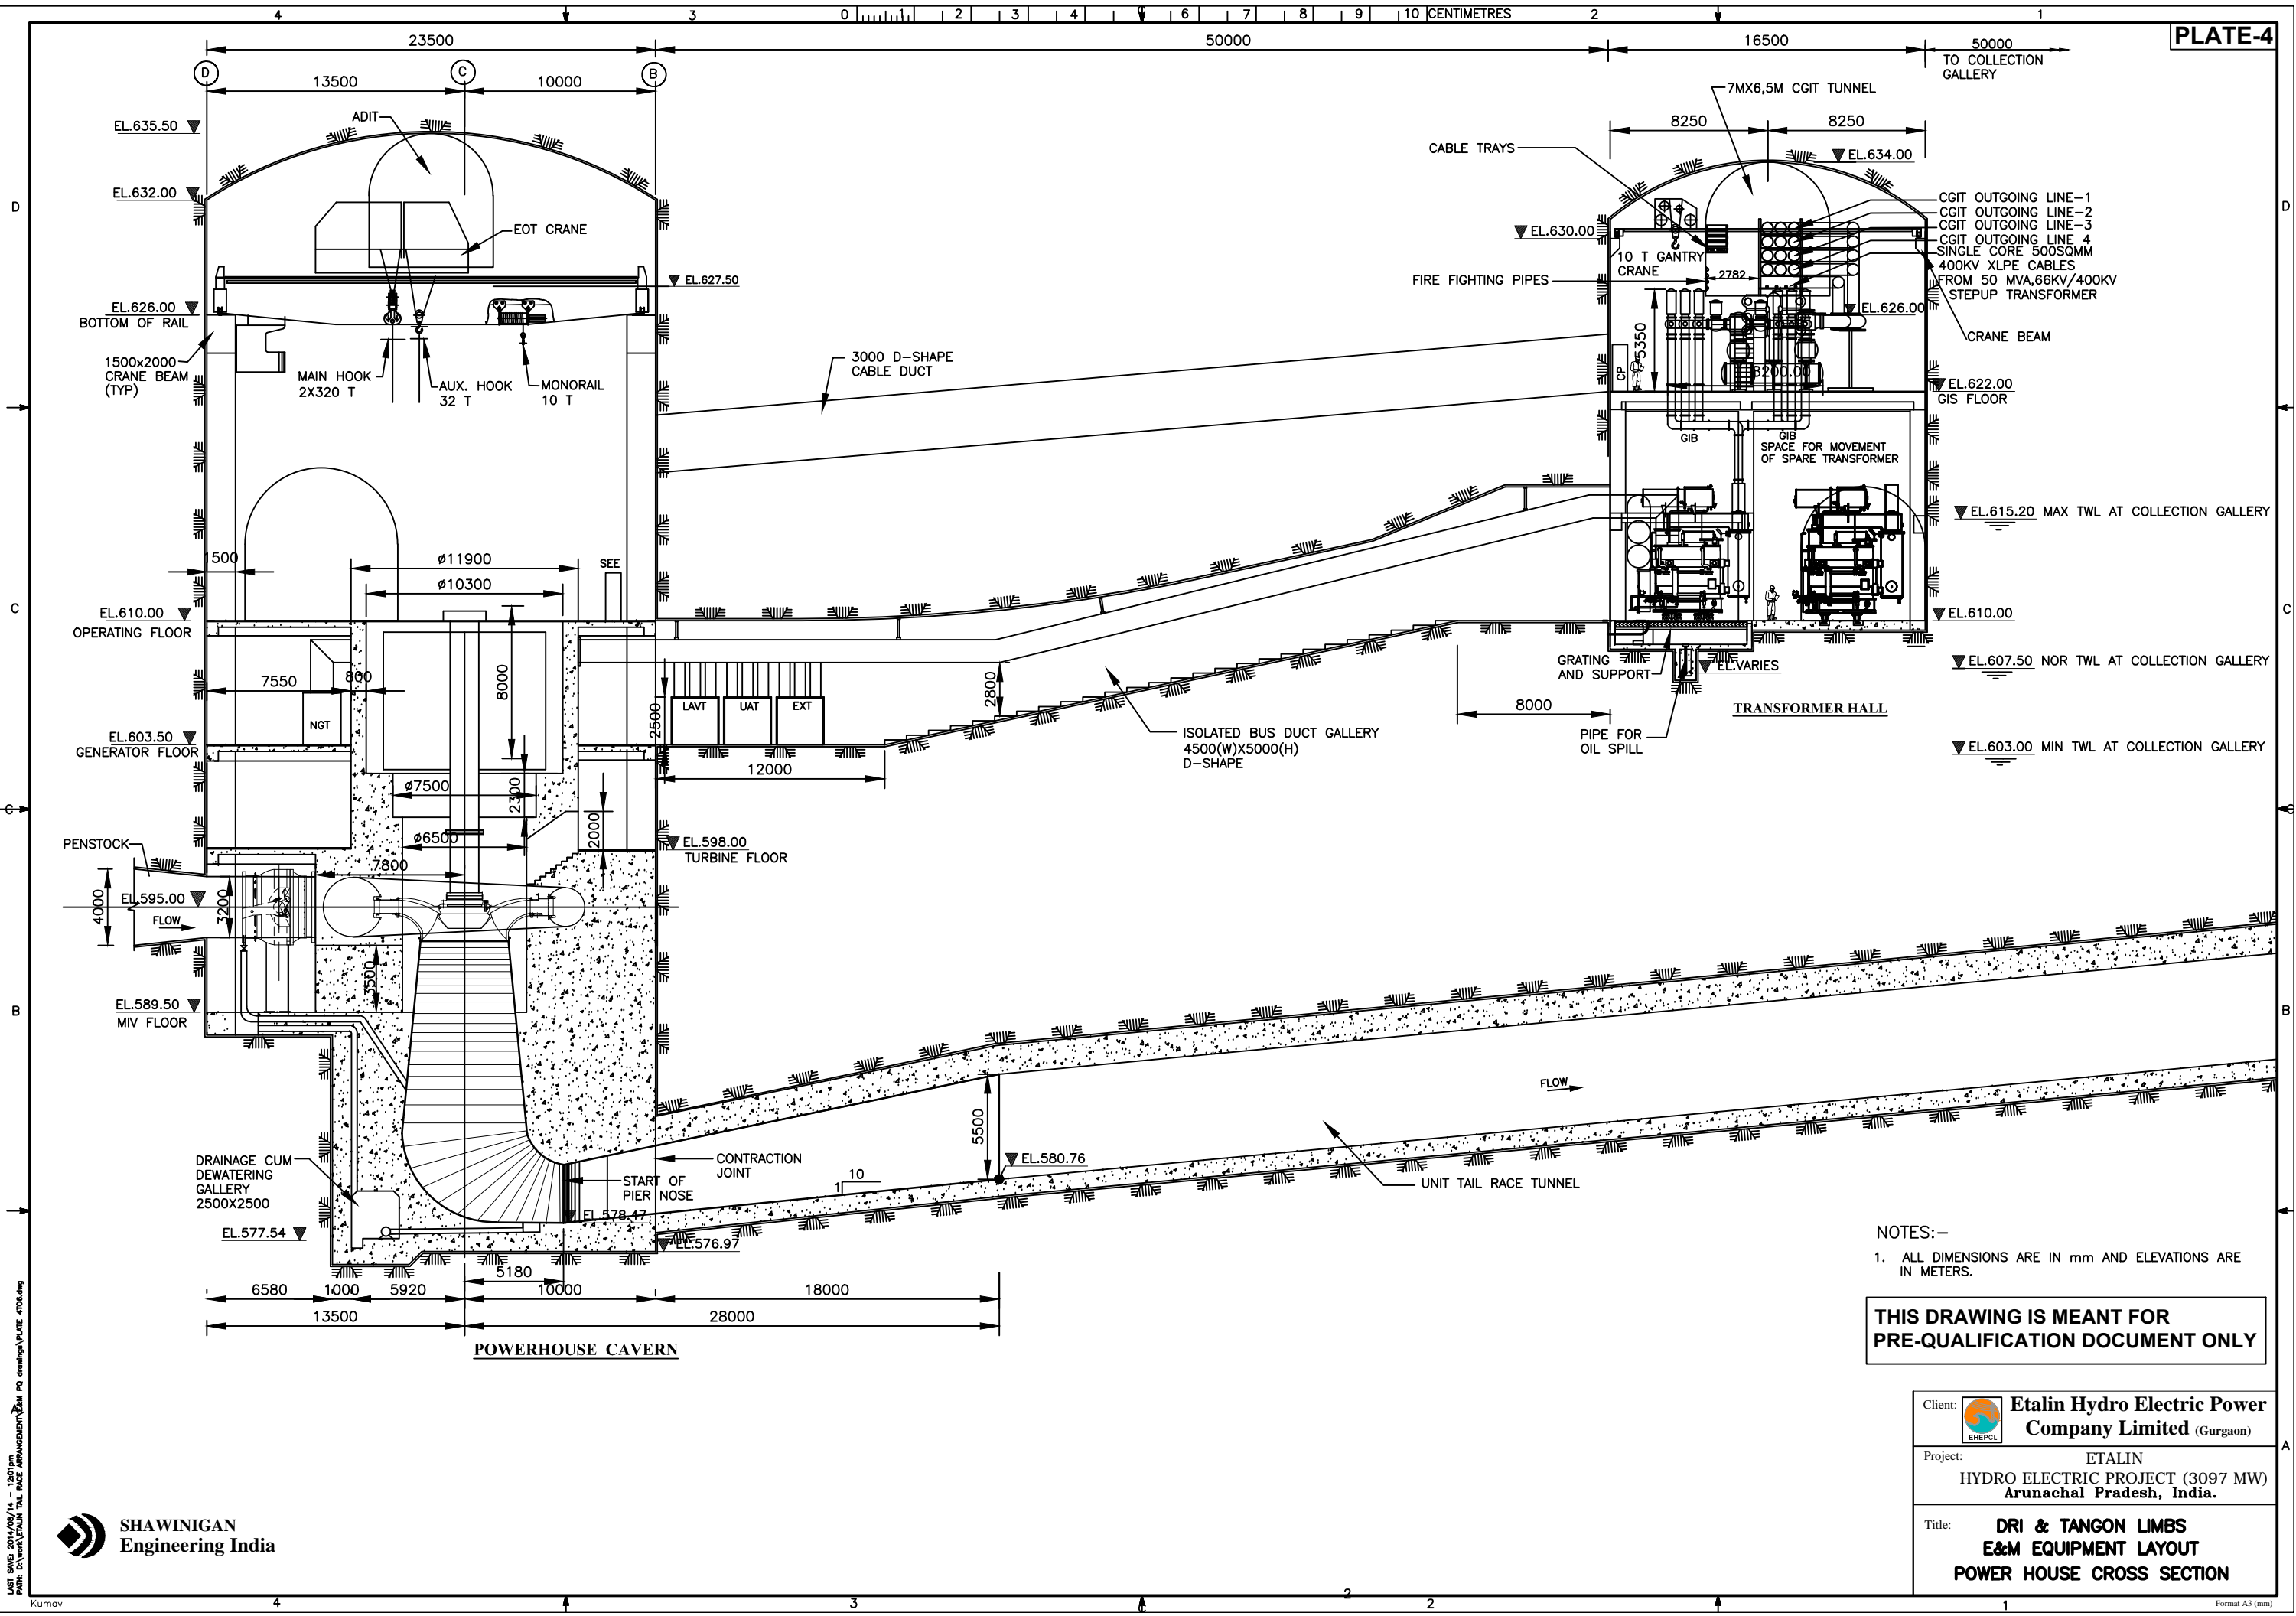


NOTES:-
 1. ALL DIMENSIONS ARE IN mm AND ELEVATIONS ARE IN METERS.

THIS DRAWING IS MEANT FOR PRE-QUALIFICATION DOCUMENT ONLY


Client:	 Etalin Hydro Electric Power Company Limited (Gurgaon)
Project:	ETALIN HYDRO ELECTRIC PROJECT (3097 MW) Arunachal Pradesh, India.
Title:	DRI & TANGON LIMBS E&M EQUIPMENT LAYOUT POWER HOUSE CROSS SECTION

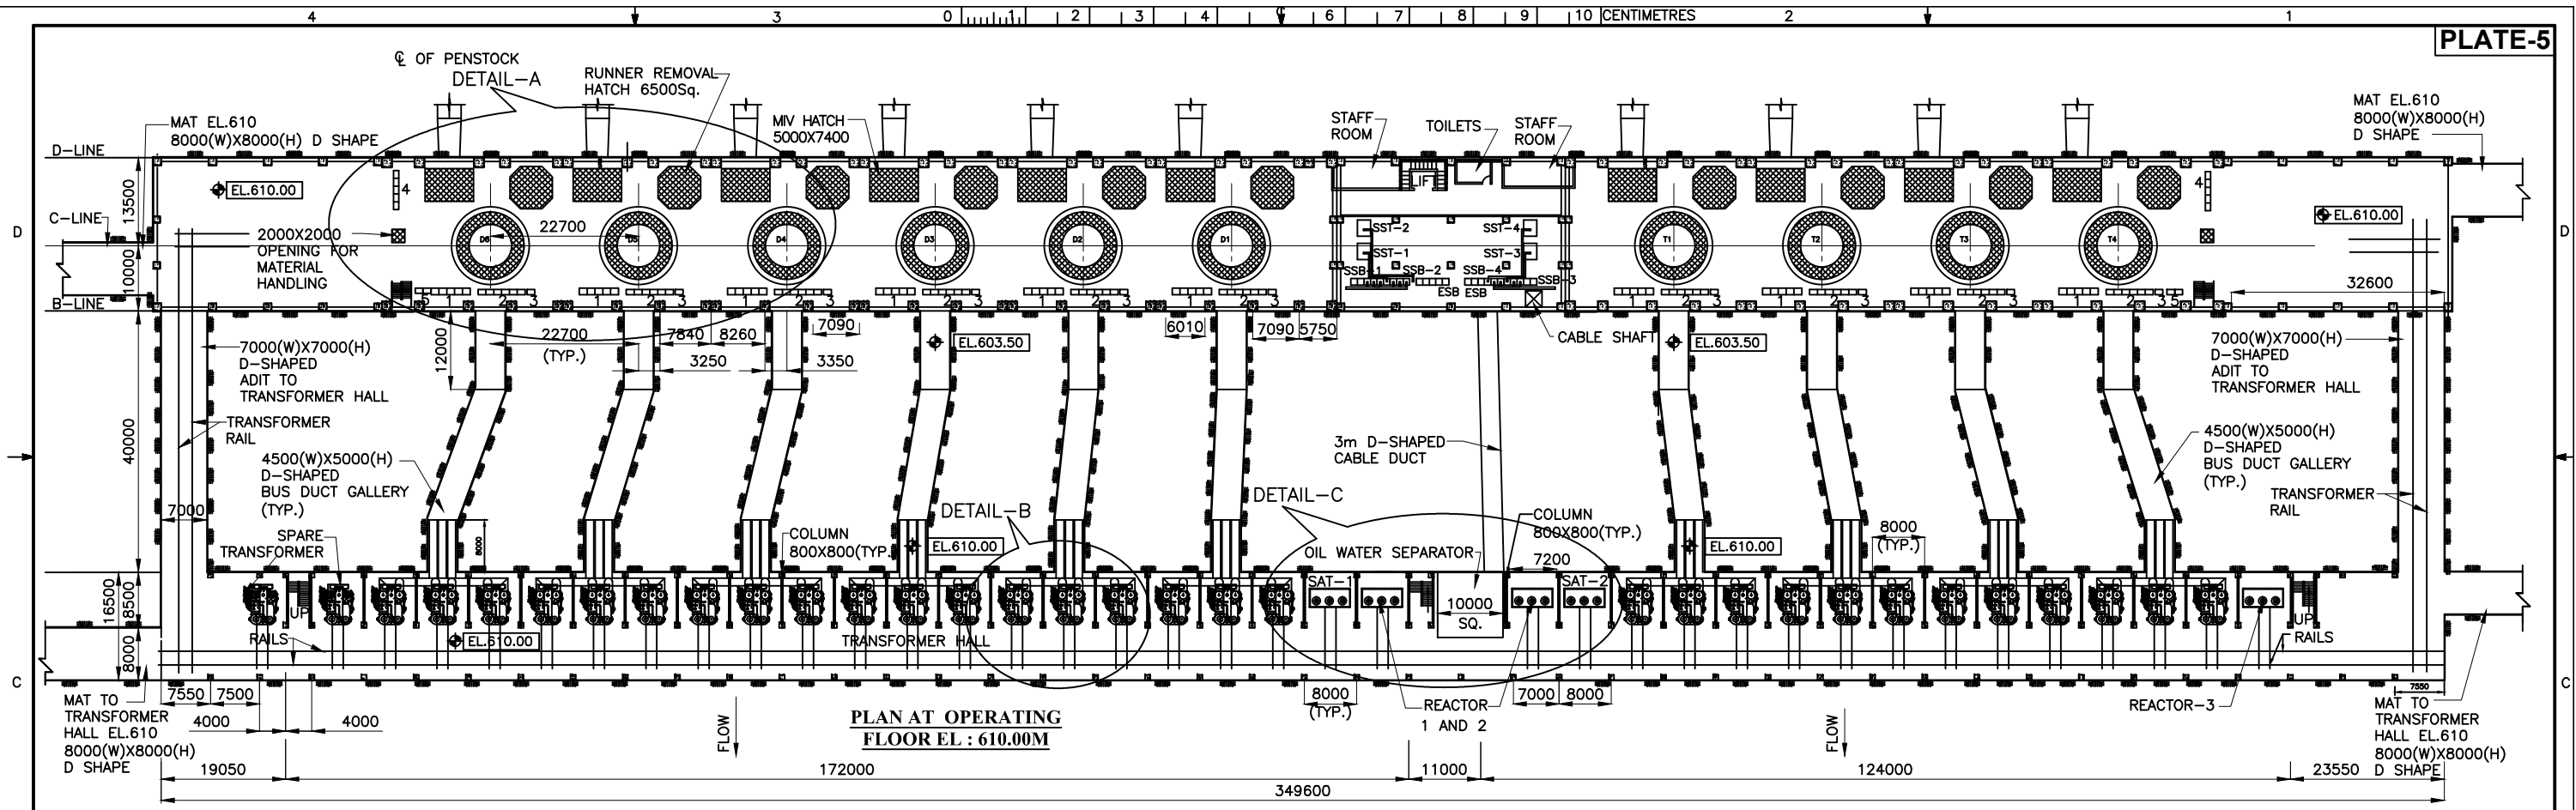


PLAN AT OPERATING FLOOR EL : 610.00M

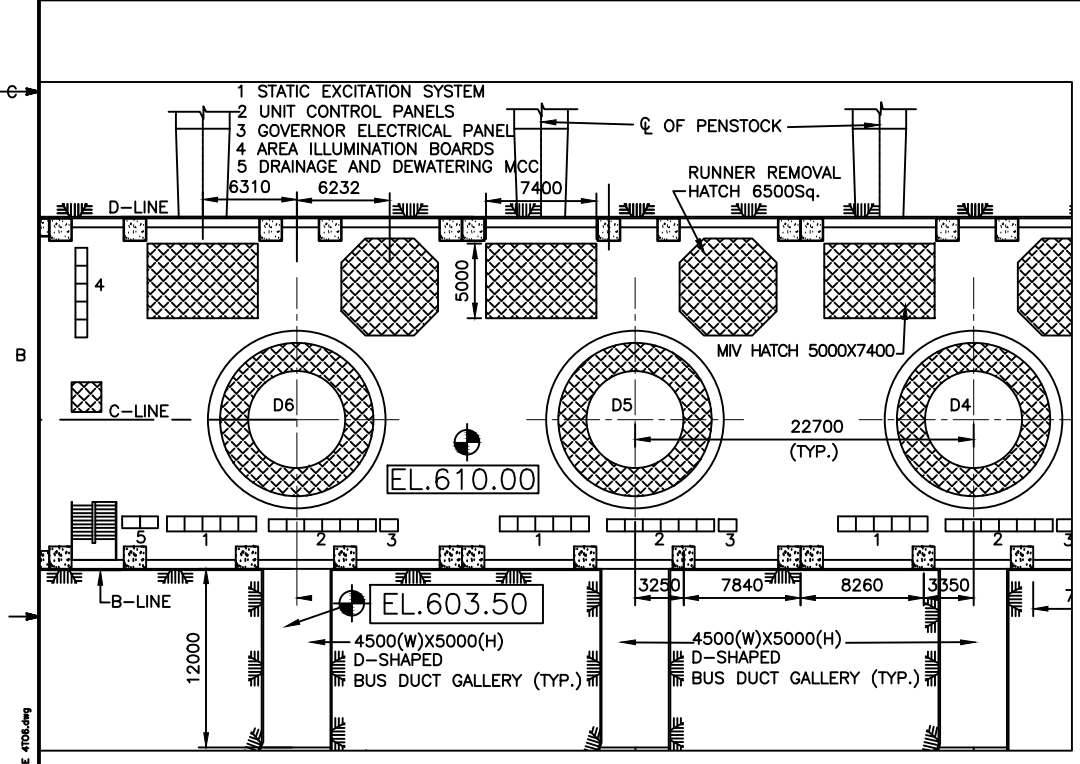

DETAIL-A

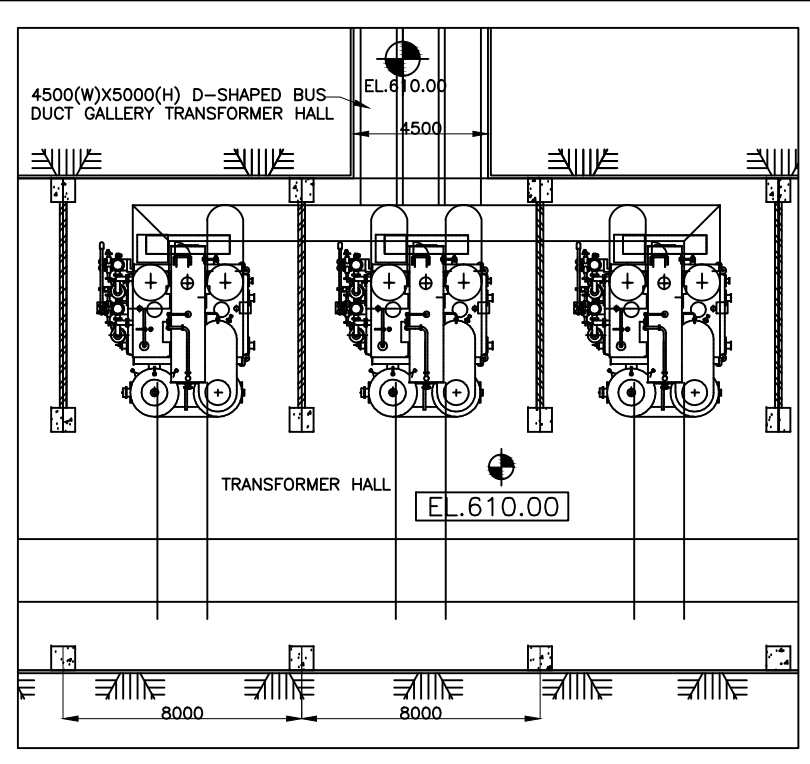

DETAIL-B

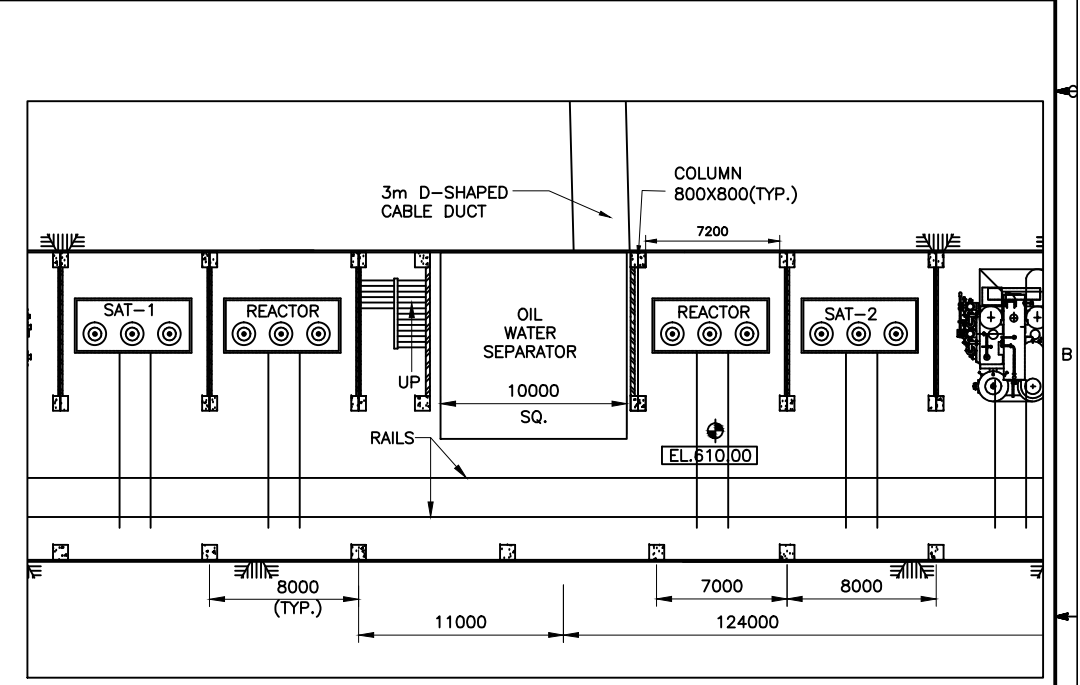


DETAIL-C

THIS DRAWING IS MEANT FOR PRE-QUALIFICATION DOCUMENT ONLY

Client:	 Etalin Hydro Electric Power Company Limited (Gurgaon)
Project:	ETALIN HYDRO ELECTRIC PROJECT (3097 MW) Arunachal Pradesh, India.
Title:	DRI & TANGON LIMBS E&M EQUIPMENT LAYOUT PLAN AT FLOOR EL 610.00

LAST DATE: 2014/09/14 - 12:50pm
PRINT: D:\Work\ETALIN Title: E&M Equipment Layout Plate 05.dwg

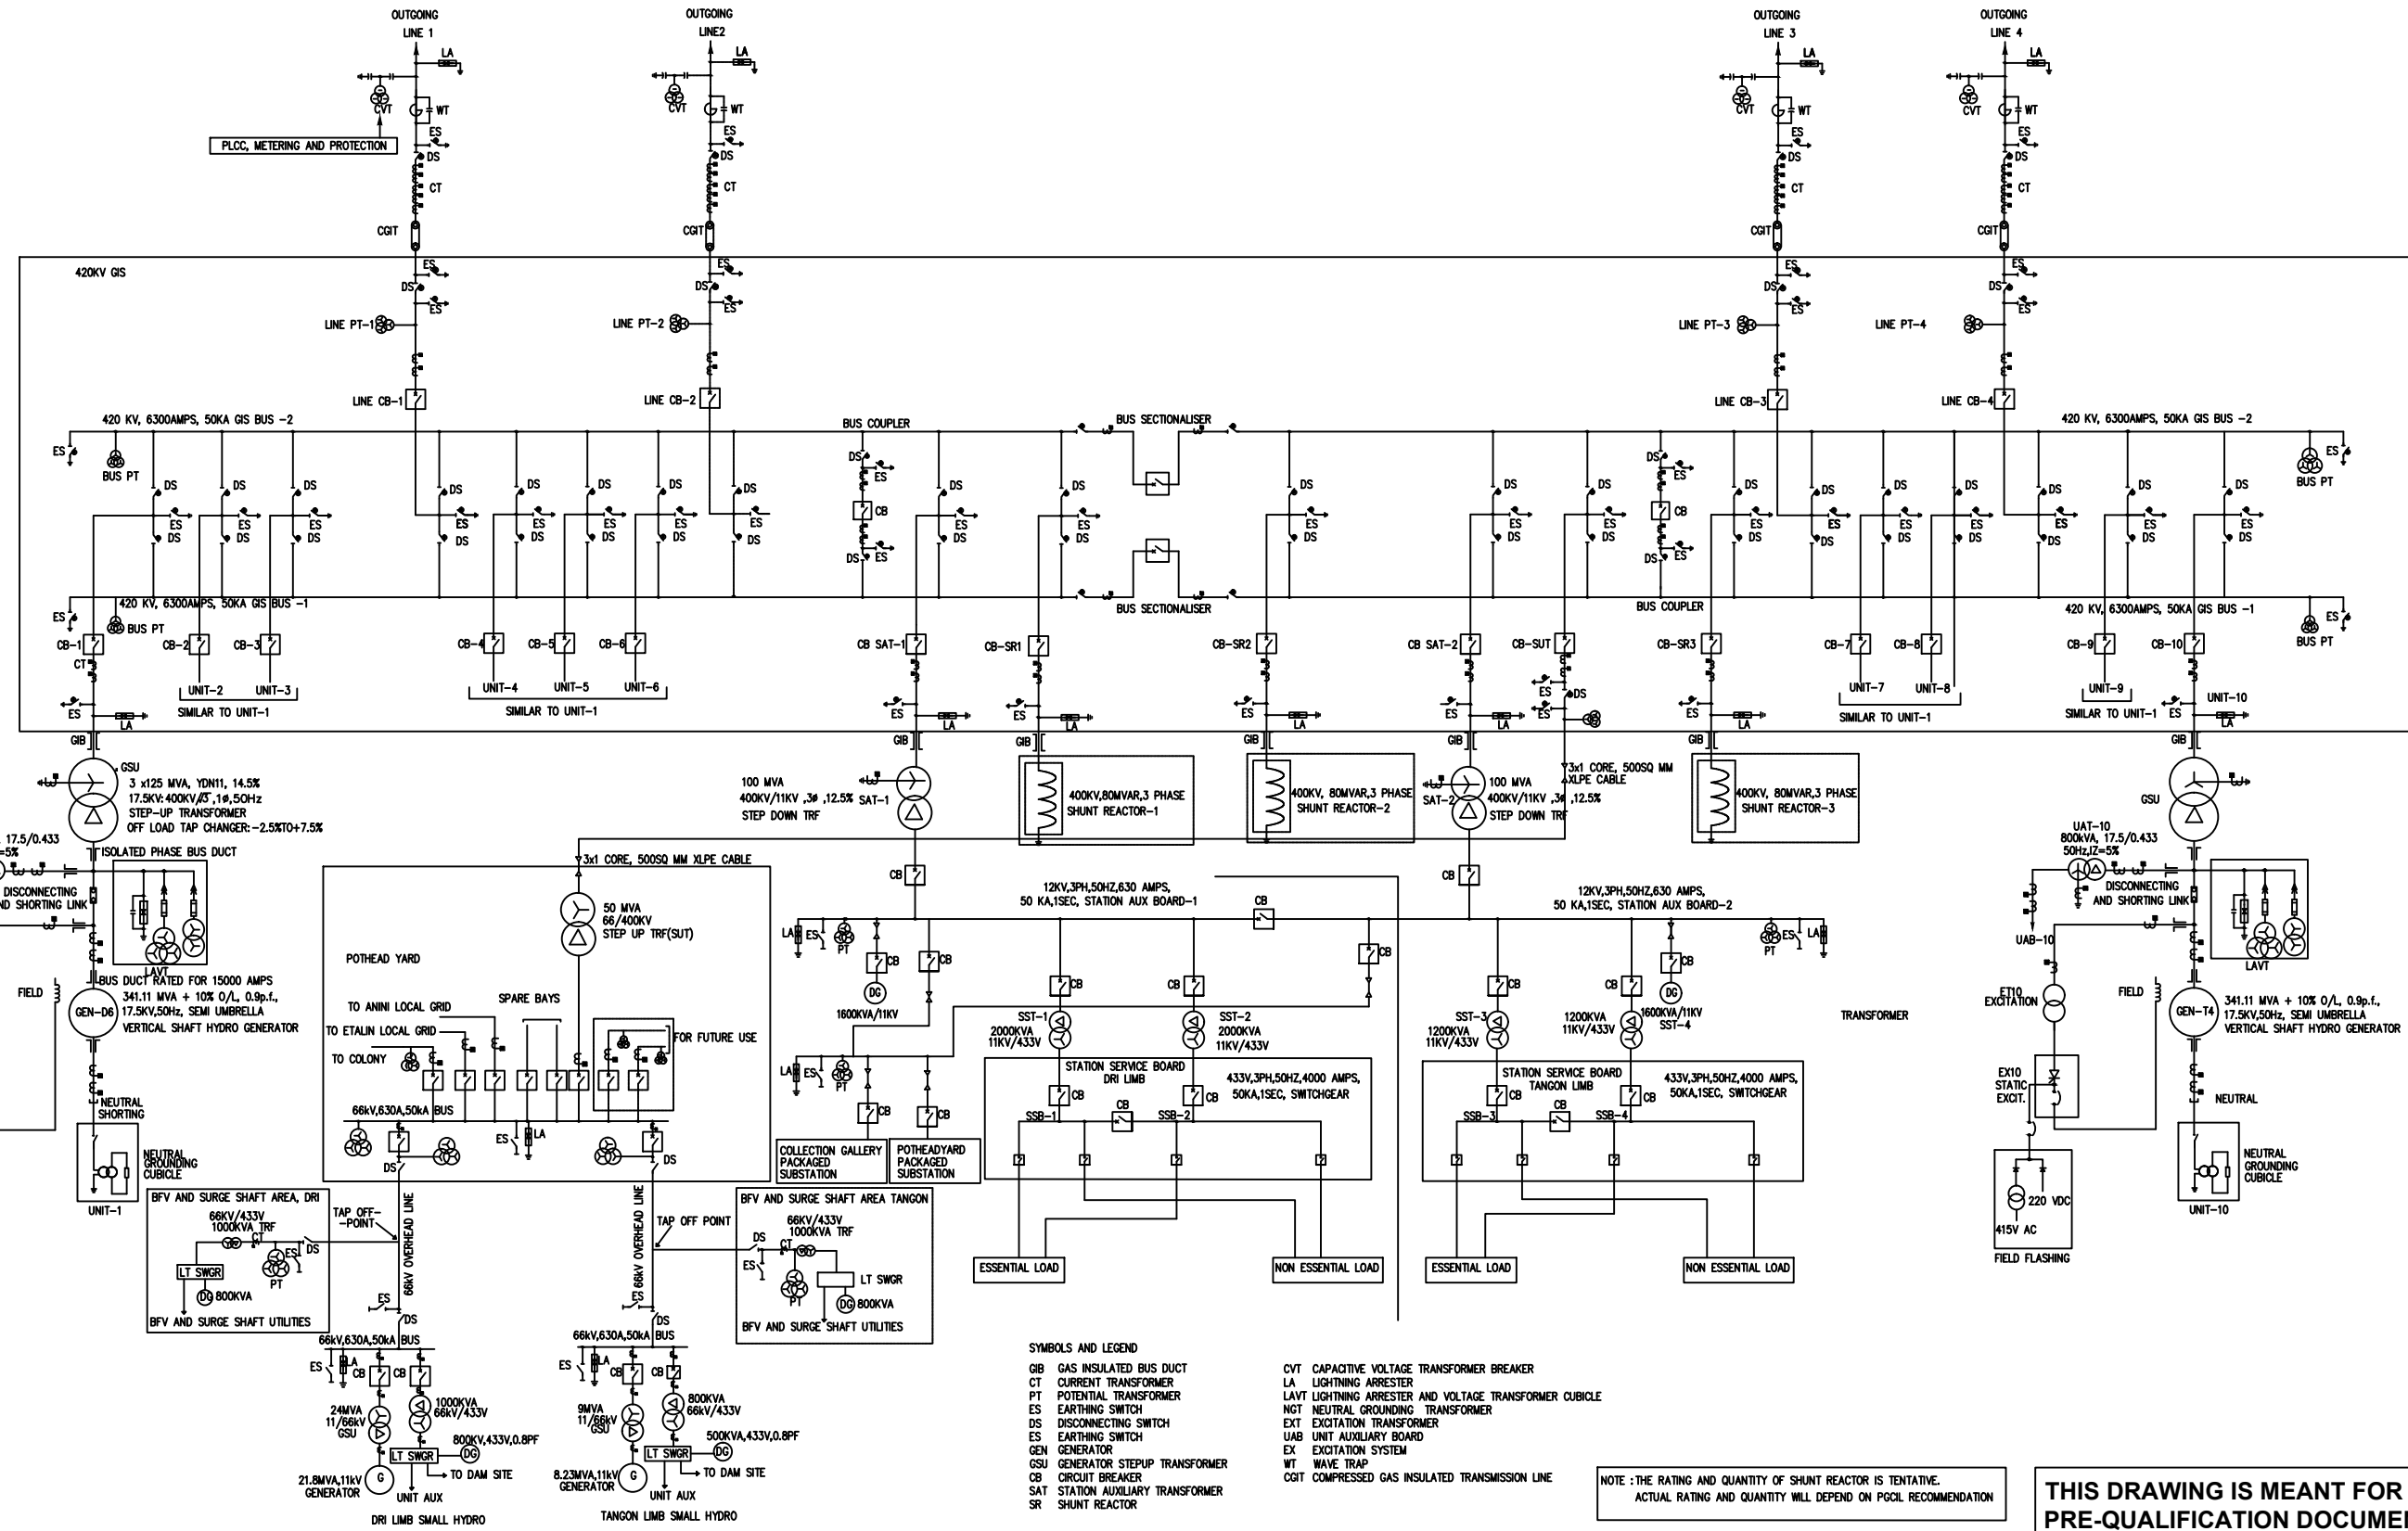

- SYMBOLS AND LEGEND**
- GIS GAS INSULATED BUS DUCT
 - CT CURRENT TRANSFORMER
 - PT POTENTIAL TRANSFORMER
 - ES EARTHING SWITCH
 - DS DISCONNECTING SWITCH
 - GEN GENERATOR
 - GSU GENERATOR STEPUP TRANSFORMER
 - CB CIRCUIT BREAKER
 - SAT STATION AUXILIARY TRANSFORMER
 - SR SHUNT REACTOR
 - CVT CAPACITIVE VOLTAGE TRANSFORMER BREAKER
 - LA LIGHTNING ARRESTER
 - LAVT LIGHTNING ARRESTER AND VOLTAGE TRANSFORMER CUBICLE
 - NGT NEUTRAL GROUNDING TRANSFORMER
 - EXT EXCITATION TRANSFORMER
 - ES EXCITATION SYSTEM
 - EX UNIT AUXILIARY BOARD
 - WT WAVE TRAP
 - CGT COMPRESSED GAS INSULATED TRANSMISSION LINE

NOTE : THE RATING AND QUANTITY OF SHUNT REACTOR IS TENTATIVE.
ACTUAL RATING AND QUANTITY WILL DEPEND ON PGCL RECOMMENDATION

**THIS DRAWING IS MEANT FOR
PRE-QUALIFICATION DOCUMENT ONLY**

Client: **Etalin Hydro Electric Power Company Limited** (Gurgaon)

Project: **ETALIN HYDRO ELECTRIC PROJECT (3097 MW) Arunachal Pradesh, India.**

Title: **DRI & TANGON LIMBS MAIN SINGLE LINE DIAGRAM**



LAST DATE: 2014/09/14 - 12:51 pm
 PRINT: D:\Work\ETALIN Title final\Announcement\Plate 6.dwg
 Kurnav